


TREE AND SHED WILL BE REMOVED
PRIOR TO INSTALLATION


PROPOSED PV
ARRAY LOCATION

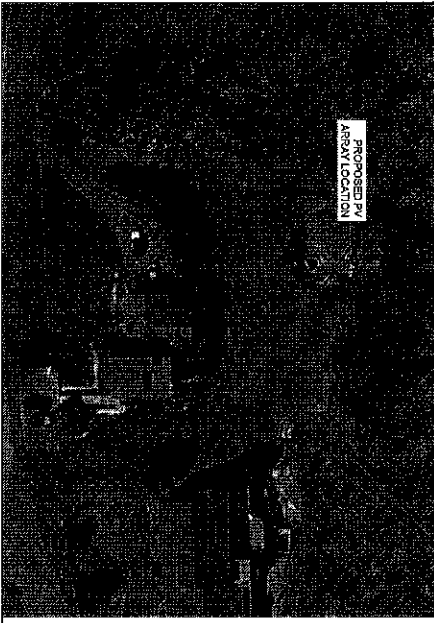

- NOTES:**
1. THIS DRAWING IS TO PROVIDE REFERENCE FOR THE INSTALLATION OF GROUND MOUNT PHOTOVOLTAIC ARRAYS.
 2. THE SYSTEM SHALL INCLUDE (700) LONG Green Energy Technology Co Ltd LRA-600PR-350K (DIMENSIONS: 68.17" (L) x 40.95"(W) x 1.42" (D)) AND WEIGHING 43.0 LBS (PANEL DEAD LOAD = 2.19PSF)
 3. THE SOLAR FOUNDATIONS PACKING WILL BE INSTALLED PER MANUFACTURER'S INSTALLATION MANUAL.
 4. THE PROPOSED ARRAY SHALL COVER APPROX. 1418 SQ.FT. OF THE 0.72 AC. PROPERTY.
 5. EQUIPMENT LOCATION PLAN IS APPROXIMATE. EXACT LOCATION TO BE VERIFIED WITH INSTALLATION CREW AND HOME OWNER AT THE TIME OF INSTALLATION

SITE PLAN
Scale 1" = 60'

EQUIPMENT LOCATION PLAN
Scale 1" = 40'

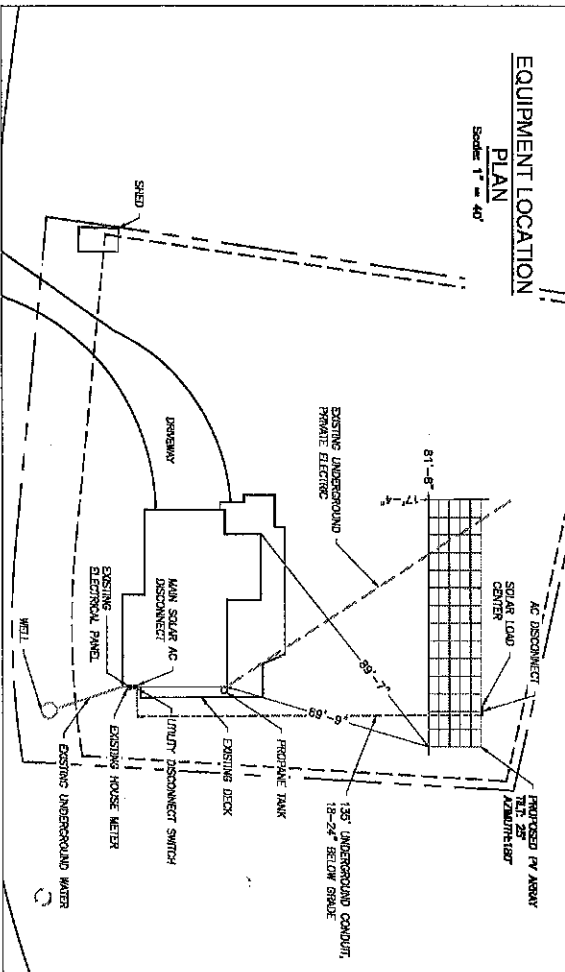

SolarEnergyWorld
Because Tomorrow Matters
Solar Energy World LLC
5681 Main Street
Elkridge, MD 21075
(888) 467-3238

This drawing is the property of Solar Energy World LLC. The content of this drawing is the confidential information of Solar Energy World LLC. It shall not be disclosed to others outside the recipient organization, in whole or in part, without the prior written consent of Solar Energy World LLC. The recipient shall be responsible for the safe and sound use of the respective Solar Energy equipment.

STANDARD AND SPECIFIC FOR STRUCTURE USA ONLY

Drawn by: Deborah Panik
SLSX14C
1819 Brickyard Road
Arlington, PA 18104
Lehigh County
PA14284
24.85 kW

Issue No: 29-MAR-2023
Date: 29-MAR-2023
Scale: AS NOTED

A001